

REF: 'X3' LUMINAIRES

20W, IP66, IK09, 2053LM, 4000K ROOT
MOUNTED MAST LED LUMINAIRE MOUNTED
@6m ON LIGHTING COLUMN.

DIMS: 598 (L) x 232 (W) x 149mm(H)



AS PER LUMINAIRE SCHEDULE

REF: 'X5' LUMINAIRES

21W, 2330lm, 4000k, IP65, IK08, POLE
MOUNTED LUMINAIRE ON 4m HIGH
COLUMN.



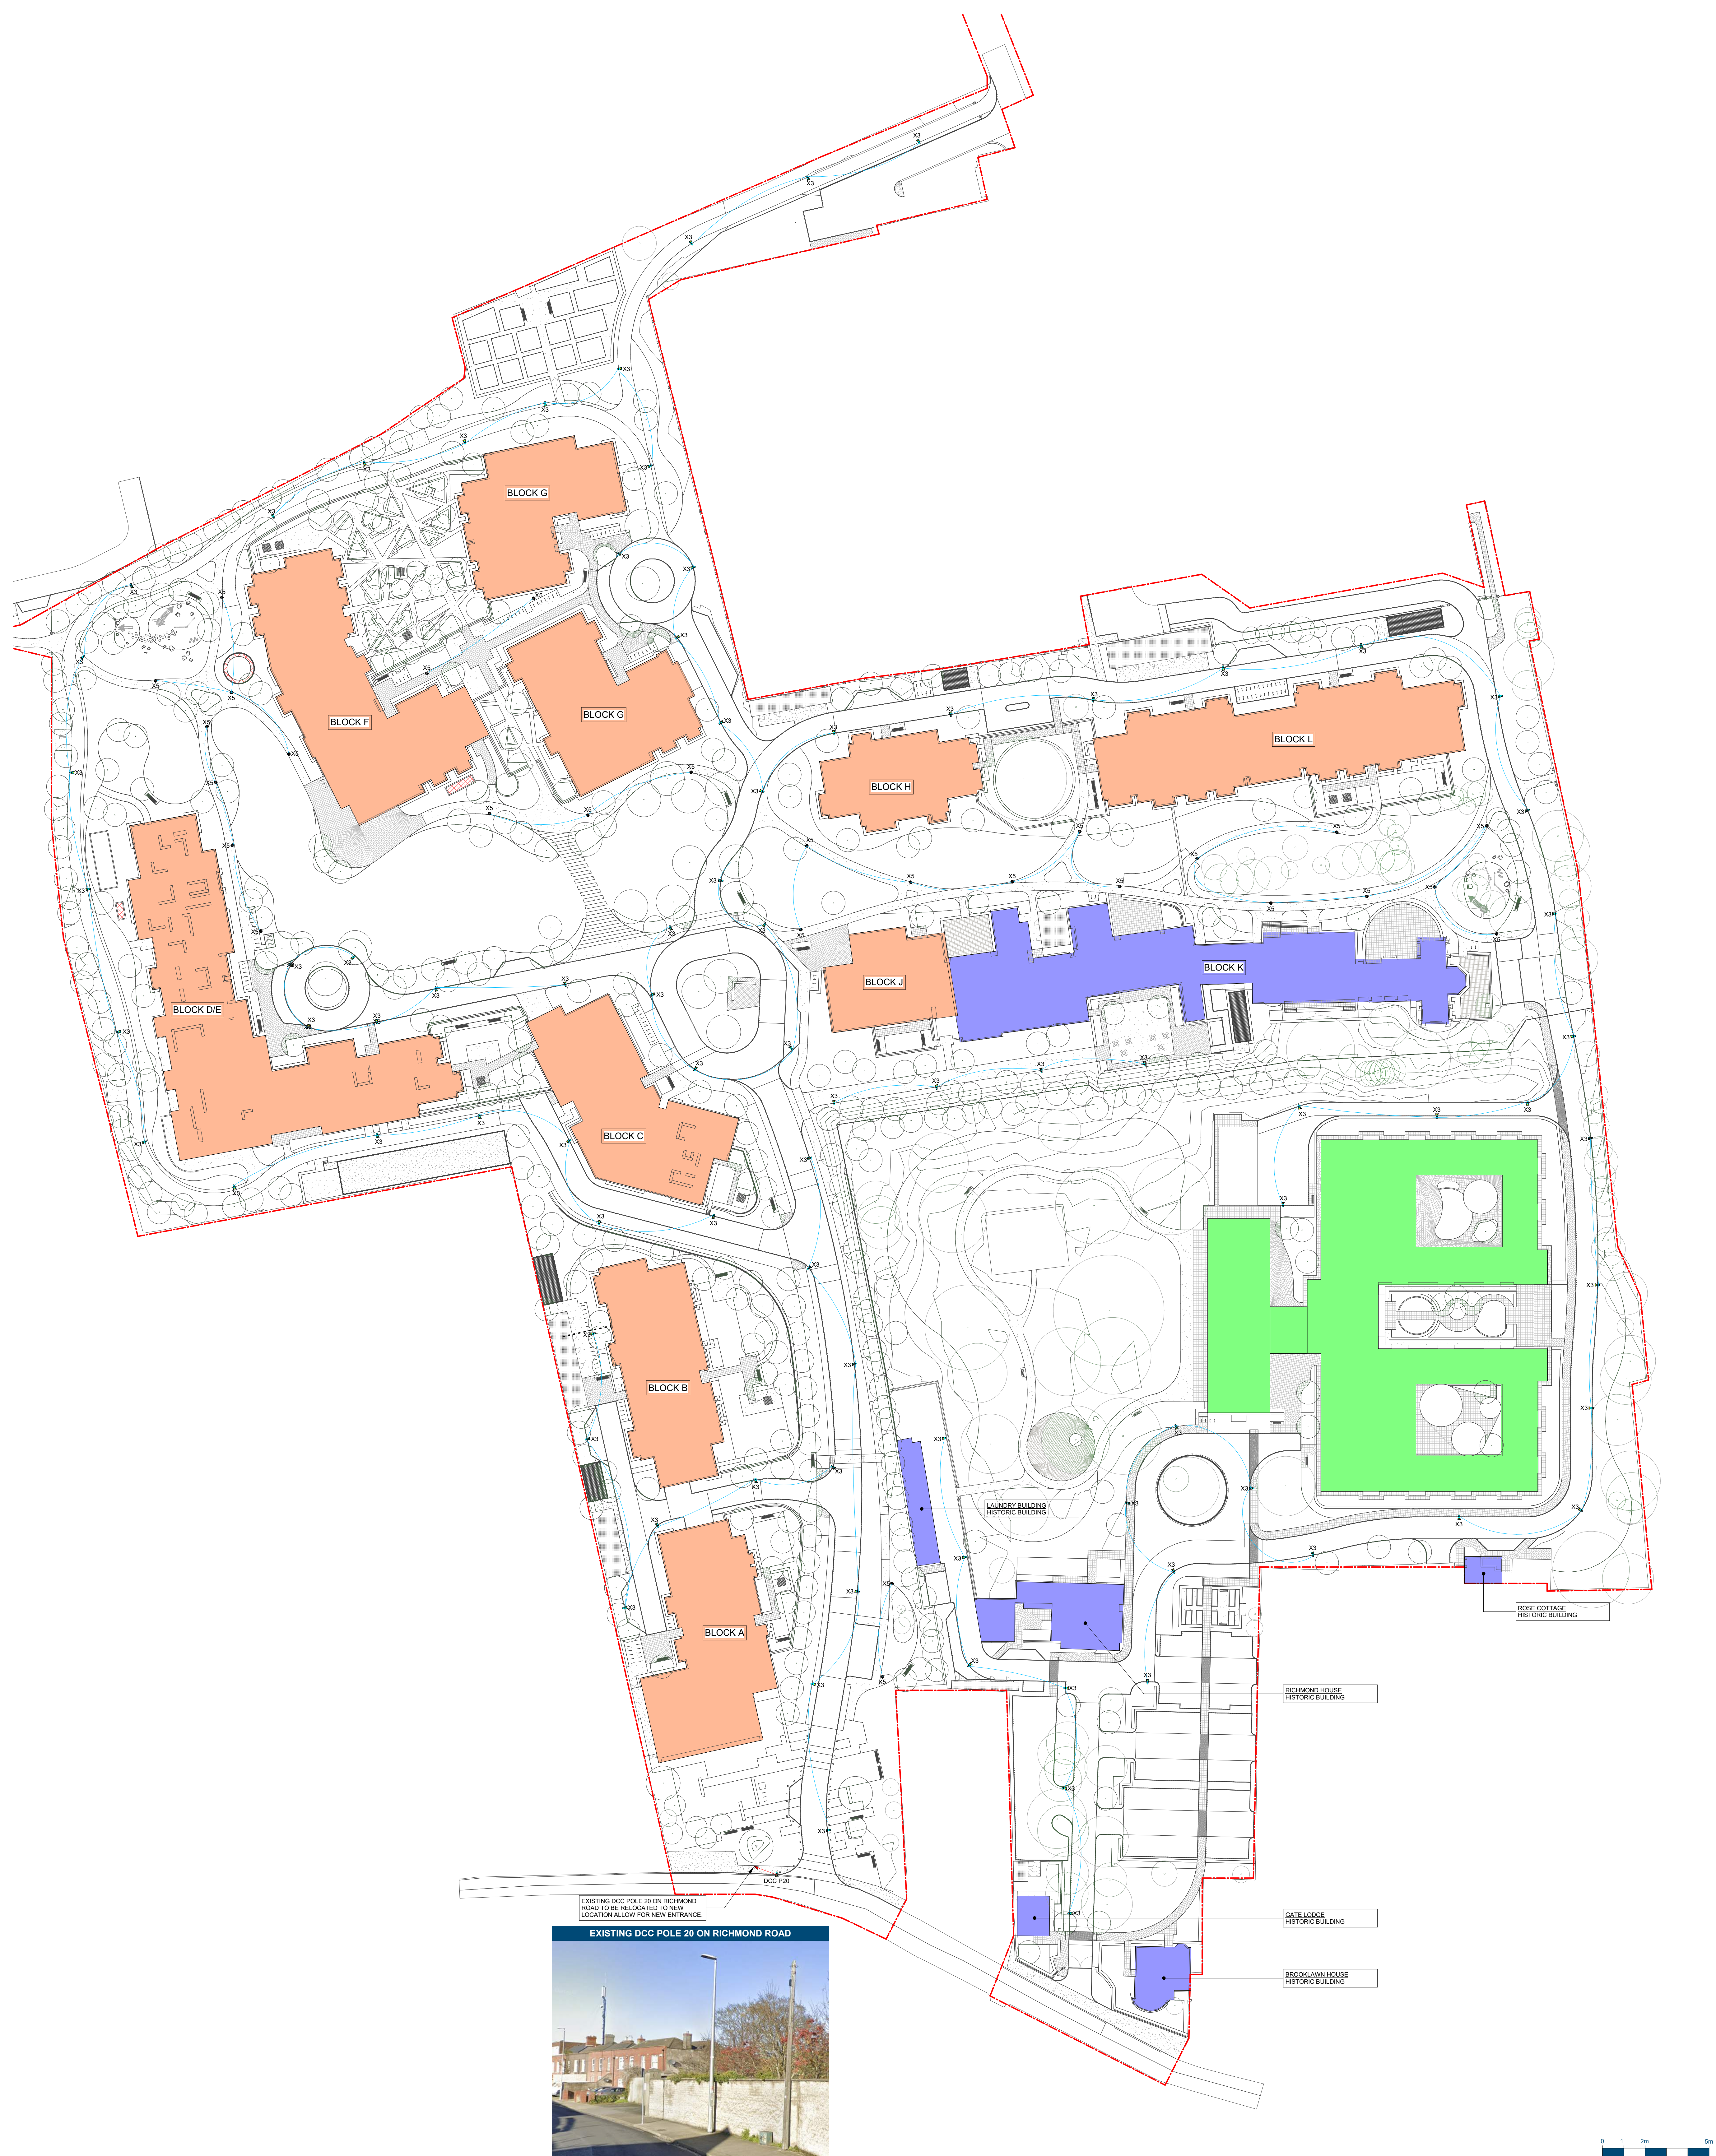
AS PER LUMINAIRE SCHEDULE

SITE LIGHTING REFERENCE KEY

LIGHTING CIRCUIT	
X3	28W LED ROOT MOUNTED MAST LUMINAIRE ON 6m COLUMN
X5	LANTERN LUMINAIRE MOUNTED ON 4m COLUMN
LMP-#	LIGHTING MINI PILLAR

SITE LIGHTING INSTALLATION NOTES

- 1.00 ALL CABLING TO EXTERNAL LIGHTING TO BE 6mm² CU/XLPE/SWA/PVC CONTAINED WITHIN PVC DUCTS.
- 2.00 ALL IN-GROUND PVC DUCTS TO BE INSTALLED BY THE MAIN CONTRACTOR UNDER THE CO-ORDINATION OF THE ELECTRICAL CONTRACTOR.
- 3.00 THE ELECTRICAL CONTRACTOR SHALL, PRIOR TO THE INSTALLATION, VERIFY THE CAPACITY OF THE IN-GROUND DUCT NETWORK TO THE MAIN CONTRACTOR.
- 4.00 THE ELECTRICAL CONTRACTOR SHALL REFER TO IN2 ENGINEERING DRAWING No. SVHF-IN2-ST-ZZ-DR-ME-0101 FOR ROUTING OF IN-GROUND DUCTS.

[illegible]

S2	22.03.2023	ISSUED FOR PLANNING	JL	TJ	JR	P04
S2	08.03.2023	ISSUED FOR PLANNING	JL	TJ	JR	P03
S2	09.02.2023	ISSUED FOR PLANNING	JL	SOB	JR	P02
S2	17.11.2022	ISSUED FOR PLANNING	JL	JL	JR	P01
STATUS	DATE	DESCRIPTION	DRN	ENG	APP	REV

PROJECT
ST. VINCENT'S HOSPITAL FAIRVIEW REDEVELOPMENT

CLIENT
ST. VINCENT'S HOSPITAL FAIRVIEW

DRAWING TITLE
ELECTRICAL SERVICES INSTALLATION
SITE PLAN
SITE LIGHTING LAYOUT

IN2 REF:	DRAWING No.
D2116	SVRD-IN2-ST-ZZ-DR-E-0105

IN2	STATUS S2
	REVISION P04
SCALE 1 : 500	SIZE A0